




AS BUILT DRAWING

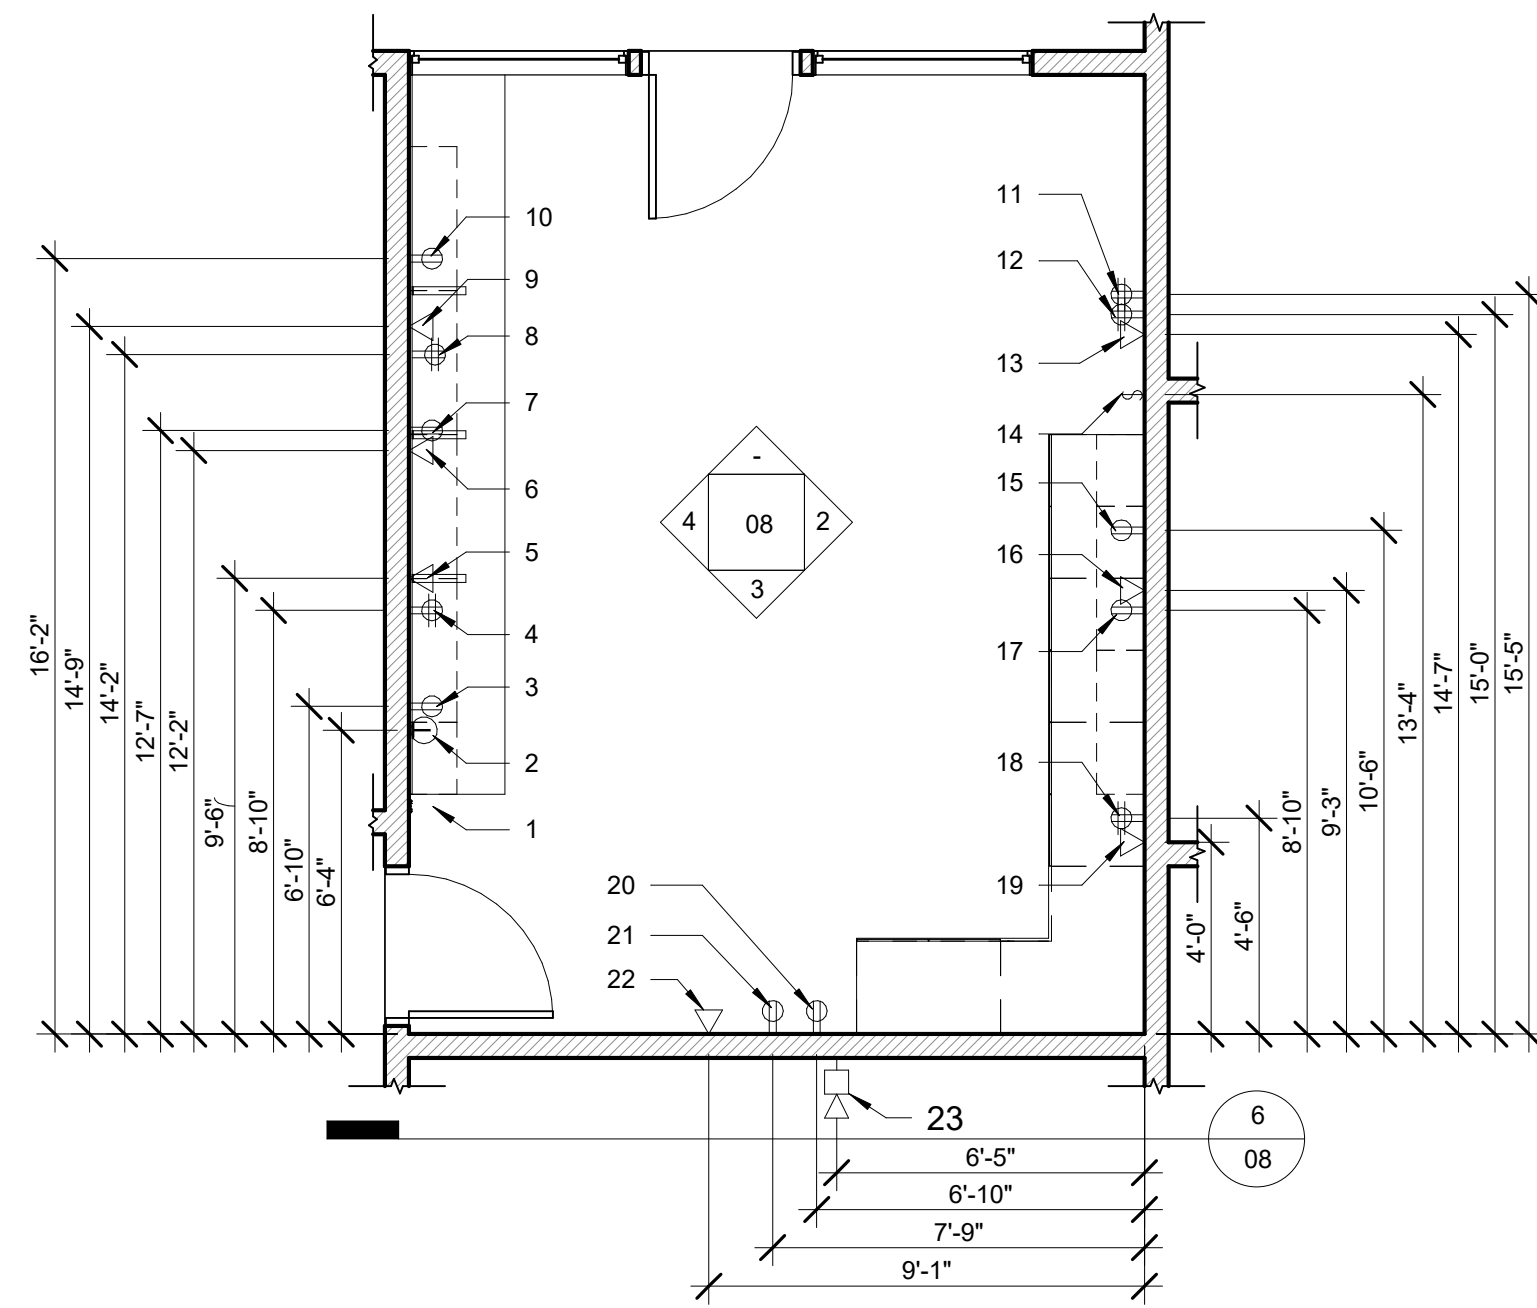


1 Level 1 - Electrical Power Plan
1/4" = 1'-0"

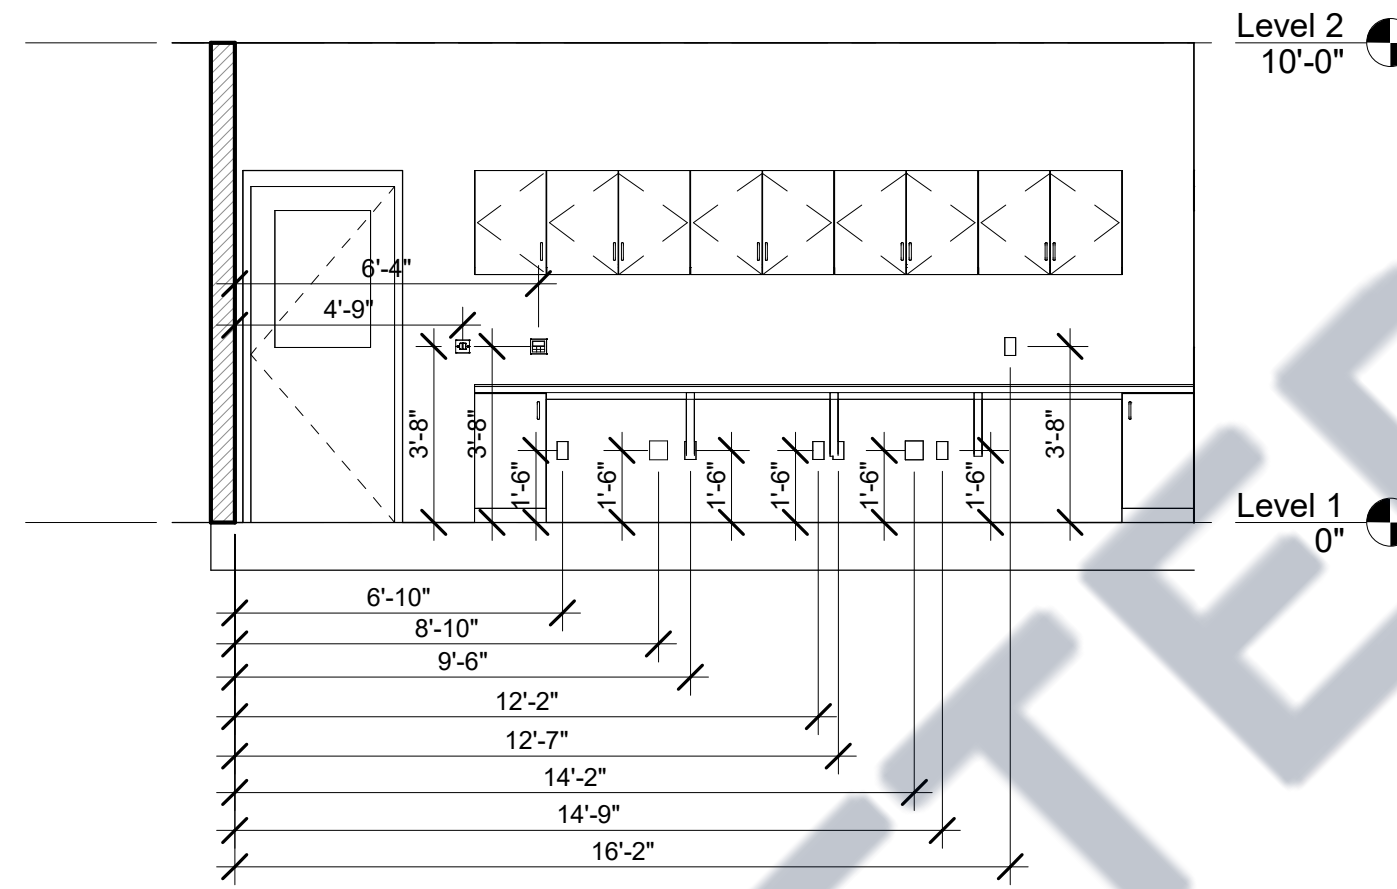


4 ELECTRICAL WEST WALL
1/4" = 1'-0"

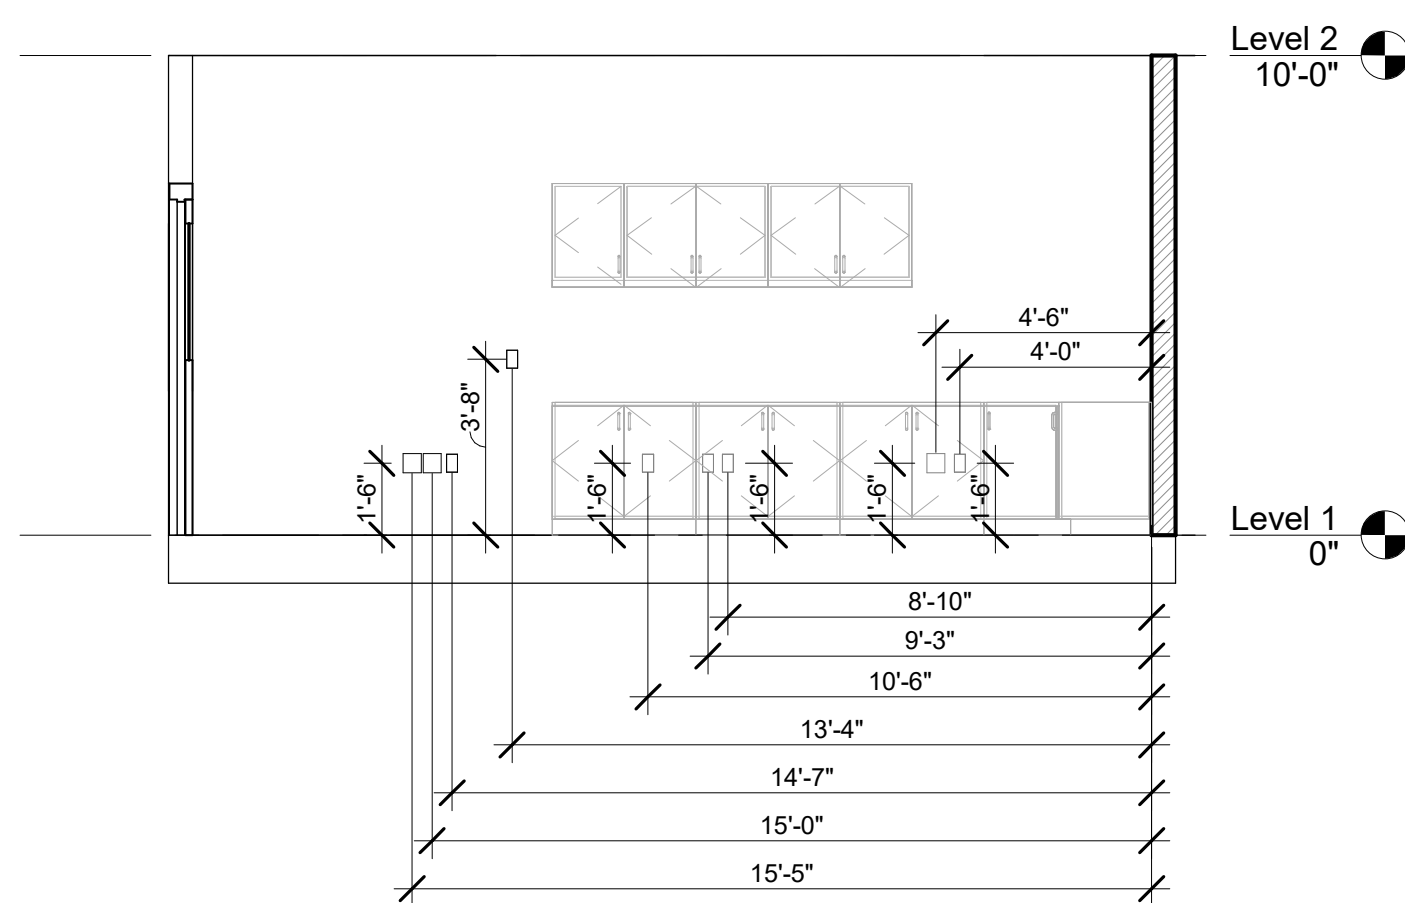

2 ELECTRICAL EAST WALL
1/4" = 1'-0"

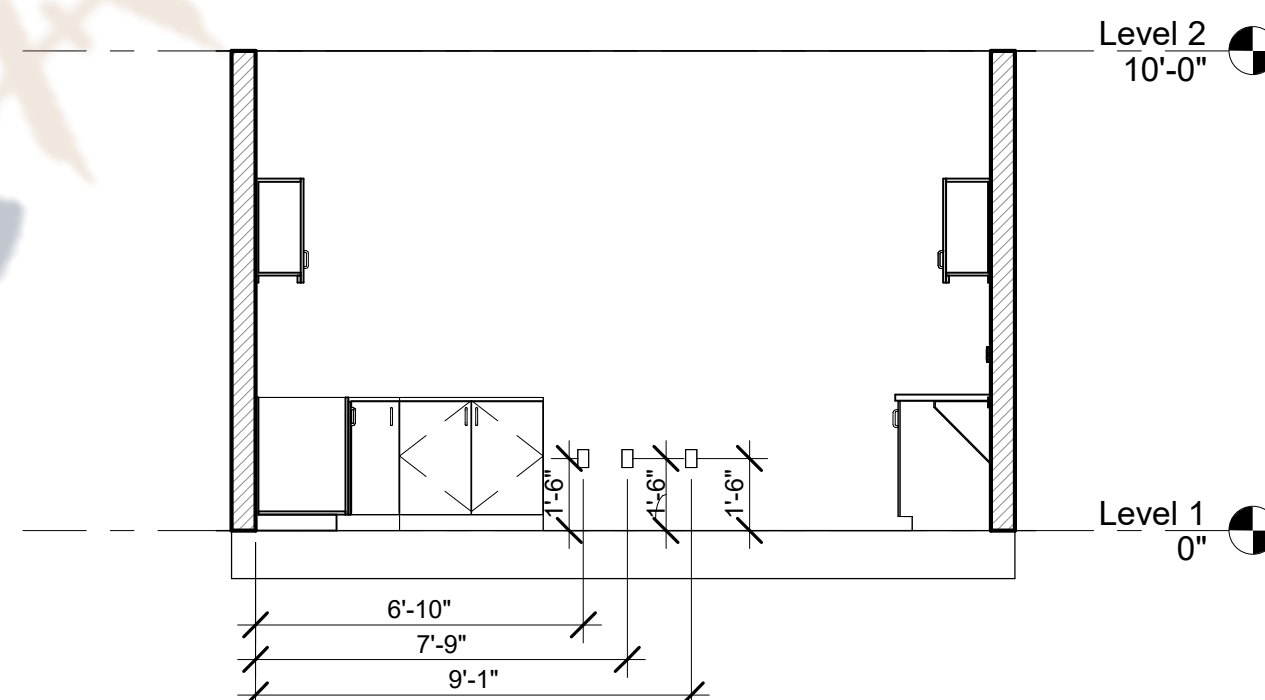

3 ELECTRICAL SOUTH WALL
1/4" = 1'-0"

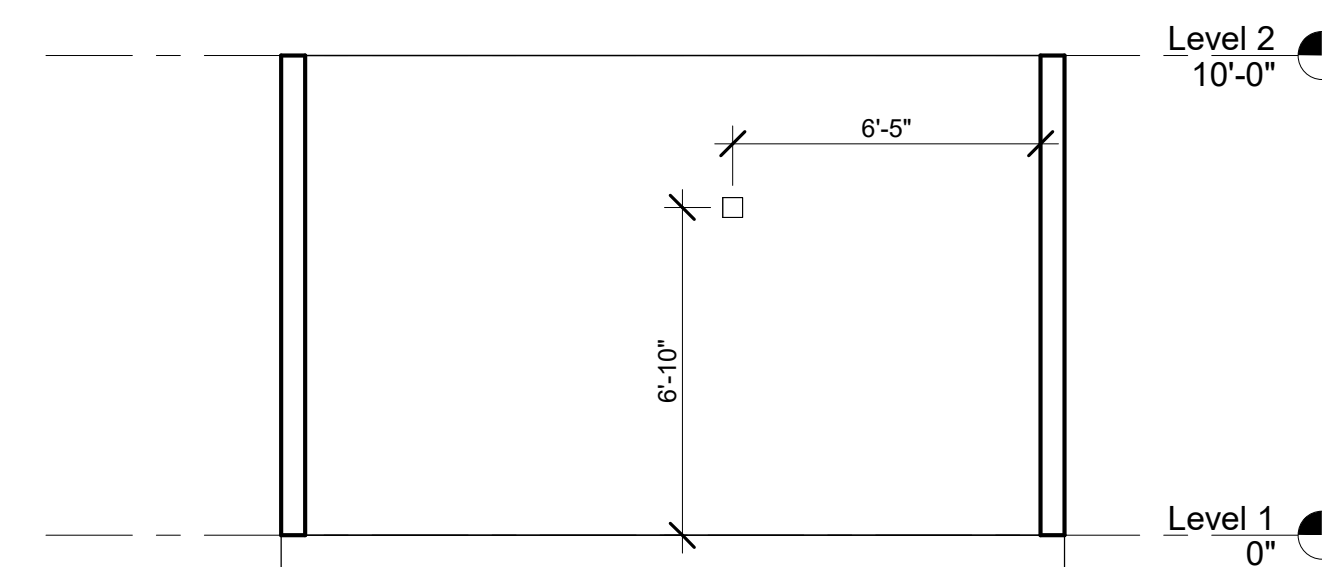


6 Section-A
1/4" = 1'-0"

SR NO	DISRIPTION	DISTANCE	HEIGHT
1	DOUBLE LIGHT SWITCH	4'-9"	3'-8"
2	THERMOSTATE	6'-4"	3'-8"
3	DUPLEX OUTLET	6'-10"	1'-6"
4	QUAD OUTLET	8'-10"	1'-6"
5	DATA JACK	9'-6"	1'-6"
6	DATA JACK	12'-2"	1'-6"
7	DUPLEX OUTLET	12'-7"	1'-6"
8	QUAD OUTLET	14'-2"	1'-6"
9	DATA JACK	14'-9"	1'-6"
10	SWITCH/DUPLEX OUTLET	16'-2"	3'-8"
11	QUAD OUTLET	15'-5"	1'-6"
12	QUAD OUTLET	15'-0"	1'-6"
13	DATA JACK	14'-7"	1'-6"
14	SINGLE SWITCH	13'-4"	3'-8"
15	DUPLEX OUTLET	10'-6"	1'-6"
16	DATA JACK	9'-3"	1'-6"
17	DUPLEX OUTLET	8'-10"	1'-6"
18	QUAD OUTLET	4'-6"	1'-6"
19	DATA JACK	4'-0"	1'-6"
20	DUPLEX OUTLET (FROM CORNER #2)	4'-0"	1'-6"
21	DUPLEX OUTLET (FROM CORNER #2)	7'-9"	1'-6"
22	DATA JACK (FROM CORNER #2)	9'-1"	1'-6"
23	FIRE ALARM (FROM CORNER #2)	6'-5"	1'-6"

No.	Description	Date

CLIENT:
UNLV
OFFICE: (+1) 702-774-8658
 University of Nevada, Las Vegas
 4505 S. Maryland Pkwy.
 Las Vegas, Nevada 89154
 P 702.895.3011

ELECTRIC CONTRACTOR:

Red Mesa Electric
 Lic - Bond - Insured Lic # 92941
 Office : (505) 863-6742 Fax : (505) 863-9099
 redmesaelectric@yahoo.com
 1001 W.Lincoln Ave. Gallup, NM 87301
 AS BUILT DATE : 11 JANUARY 2024

SIGN : _____

NOTES :

UNLV | SLC-A RENOVATION

Electrical Plan & Elevations

Project Number	23-010
Date	11 JANUARY 2024
Drawn By	SA
Checked By	SM

08

Scale 1/4" = 1'-0"